


DO NOT SCALE

- NOTES:
1. THIS DRAWING TO BE READ IN CONJUNCTION WITH THE MECHANICAL SCHEDULE AND DRAWINGS M-01 THRU M-04.
  2. DO NOT SCALE DRAWING. USE FIGURED DIMENSIONS ONLY.
  3. DRAWING BASED ON TRANSMITTED DRAWINGS, THEREFORE THE ACCURACY OF DIMENSIONS CANNOT BE GUARANTEED. VERIFY ALL DIMENSIONS AND DETAILS ON SITE BEFORE COMMENCING ANY WORK.

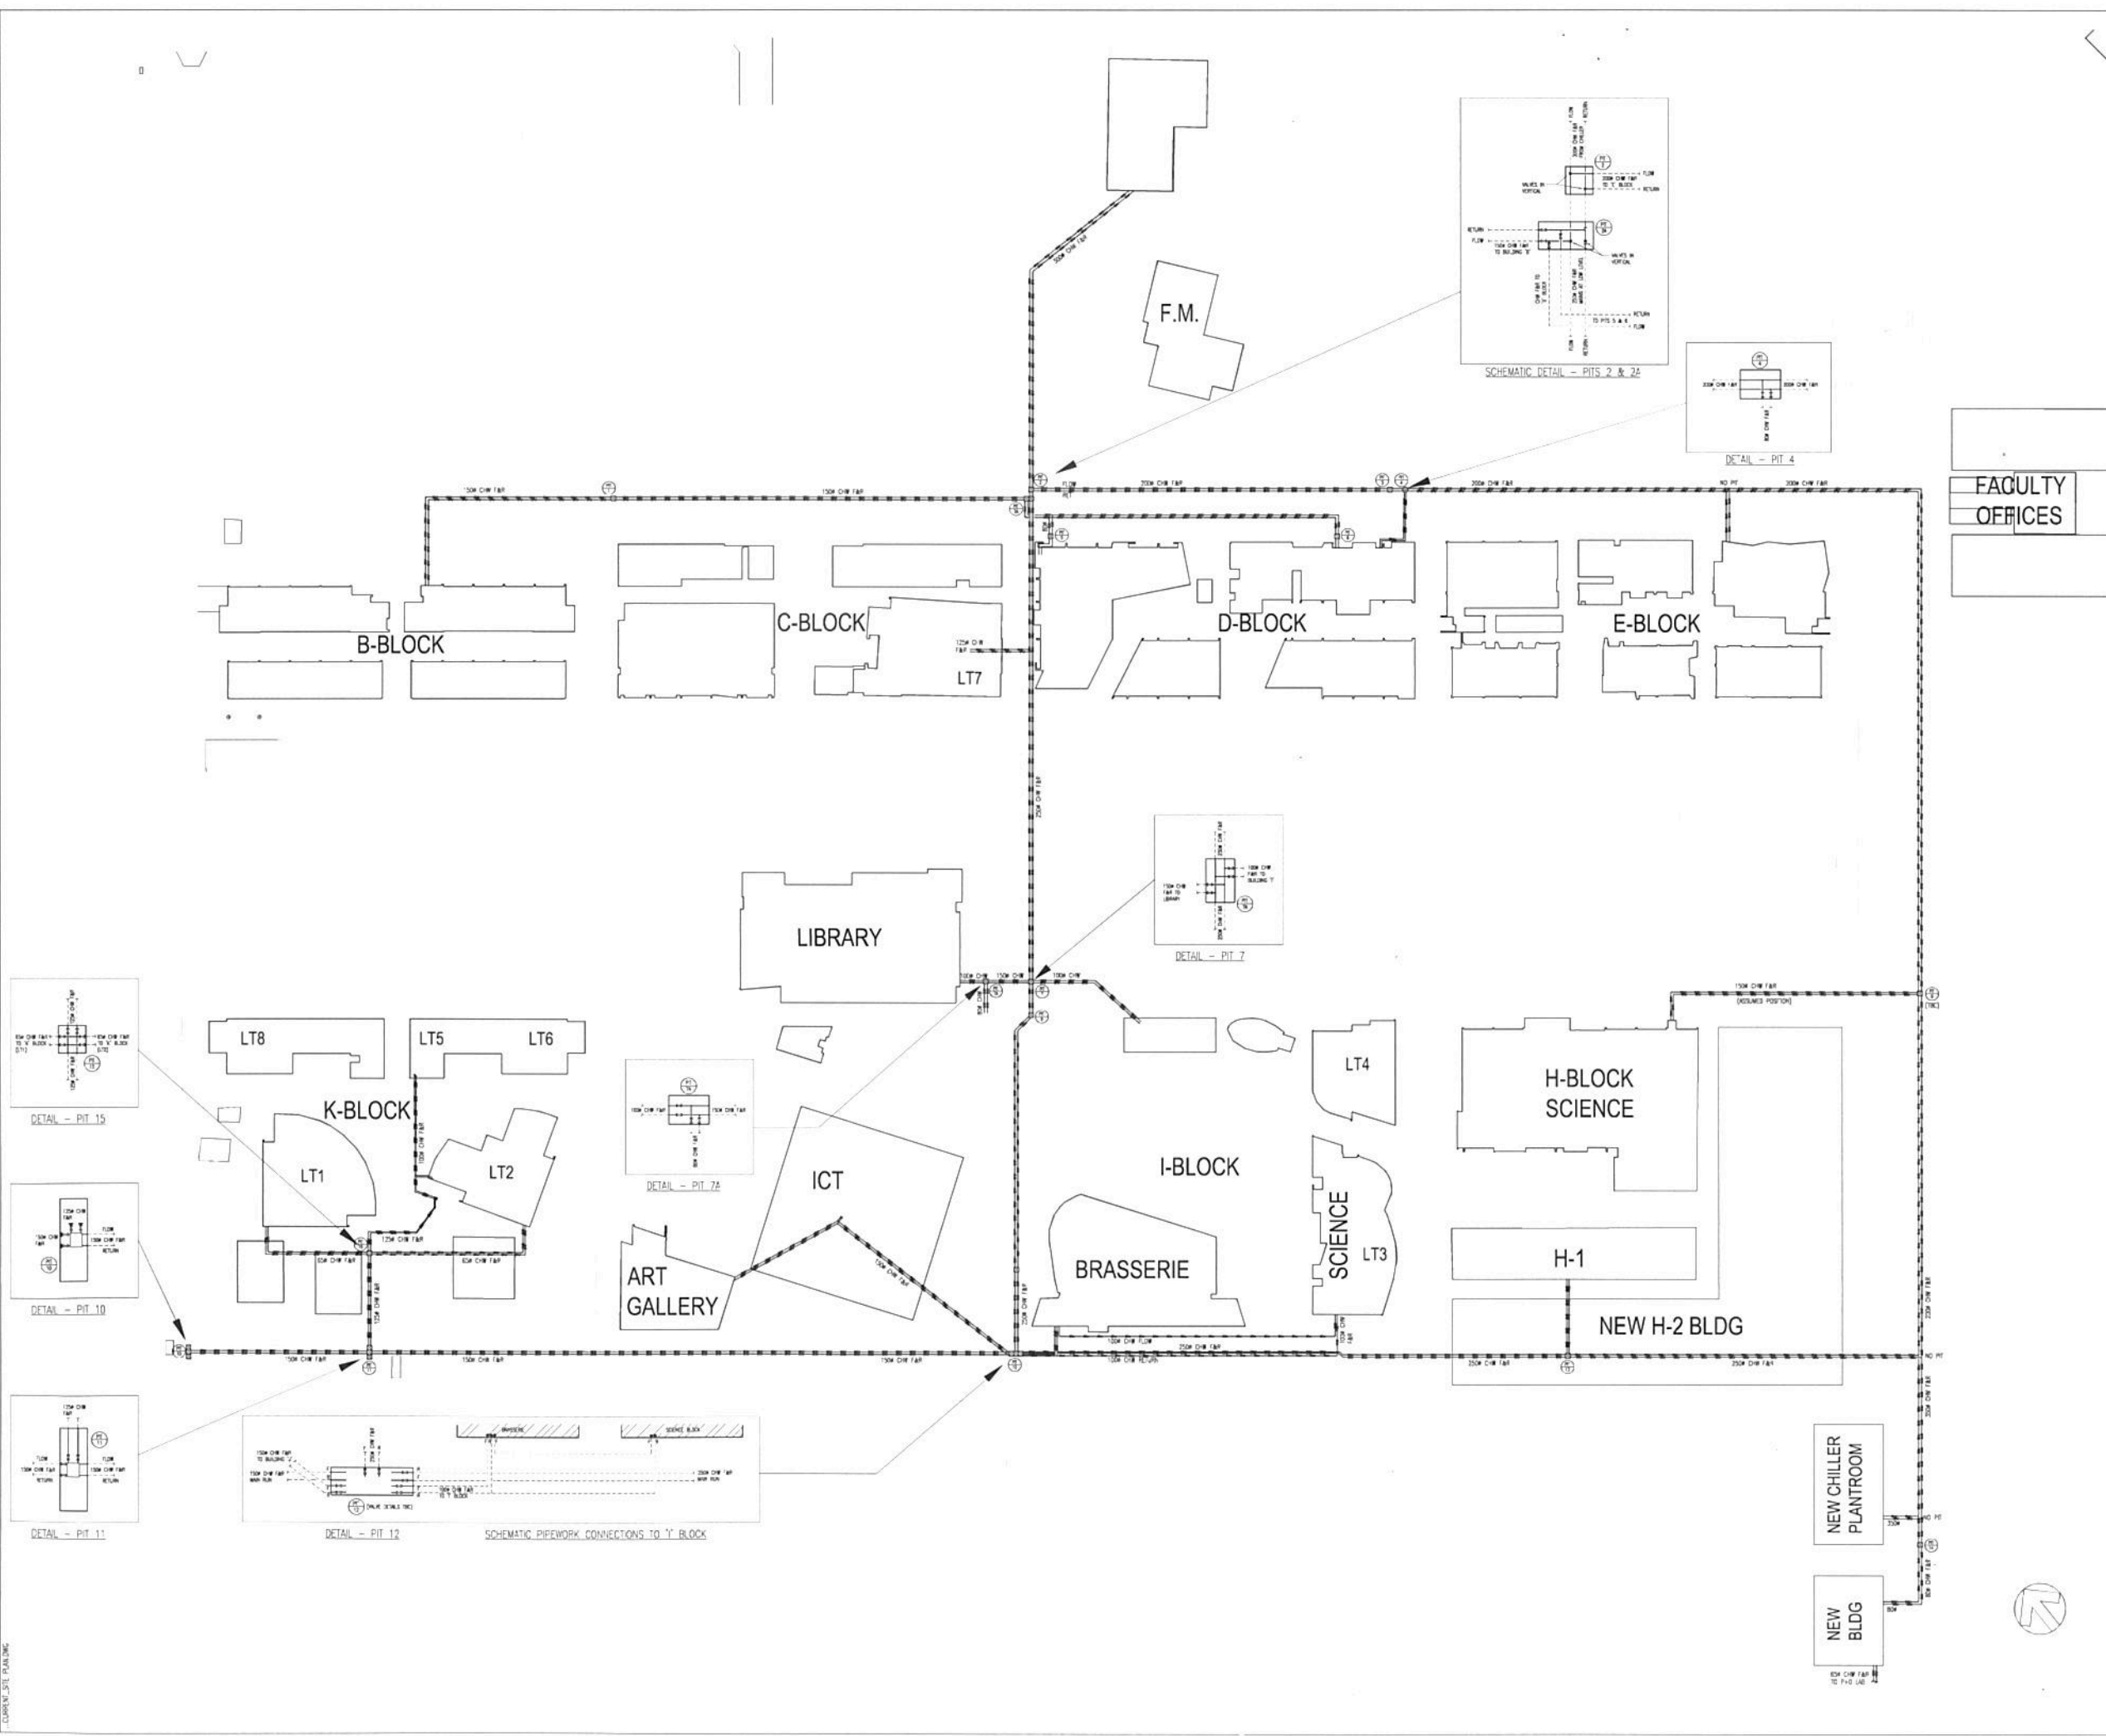

FACULTY OFFICES

**AS INSTALLED**

REV	DATE	BY	DESCRIPTION	CHK	APP
RD	17/07/17	WS	AS INSTALLED - RECORD DRAWING		

DRAWING STATUS: AS INSTALLED - RECORD DRAWING

CLIENT: UNIVERSITY OF THE SUNSHINE COAST

ARCHITECT: -

ENGINEER: -

PROJECT:

USC - SIPPY DOWNS CAMPUS  
INFRASTRUCTURE MAP

TITLE:

MECHANICAL SERVICES  
CHILLED WATER DISTRIBUTION LAYOUT  
UNDERGROUND PIPEWORK & ACCESS PITS

SCALE @ SITE:	NTS @ A1	DATE:	JULY 2014
CHECKED:		APPROVED:	
DESIGN:	WS	DRAWN:	PHE
PROJECT No:	20140701		
DRAWING No:	M-01 of 1	SHEETS:	RD